




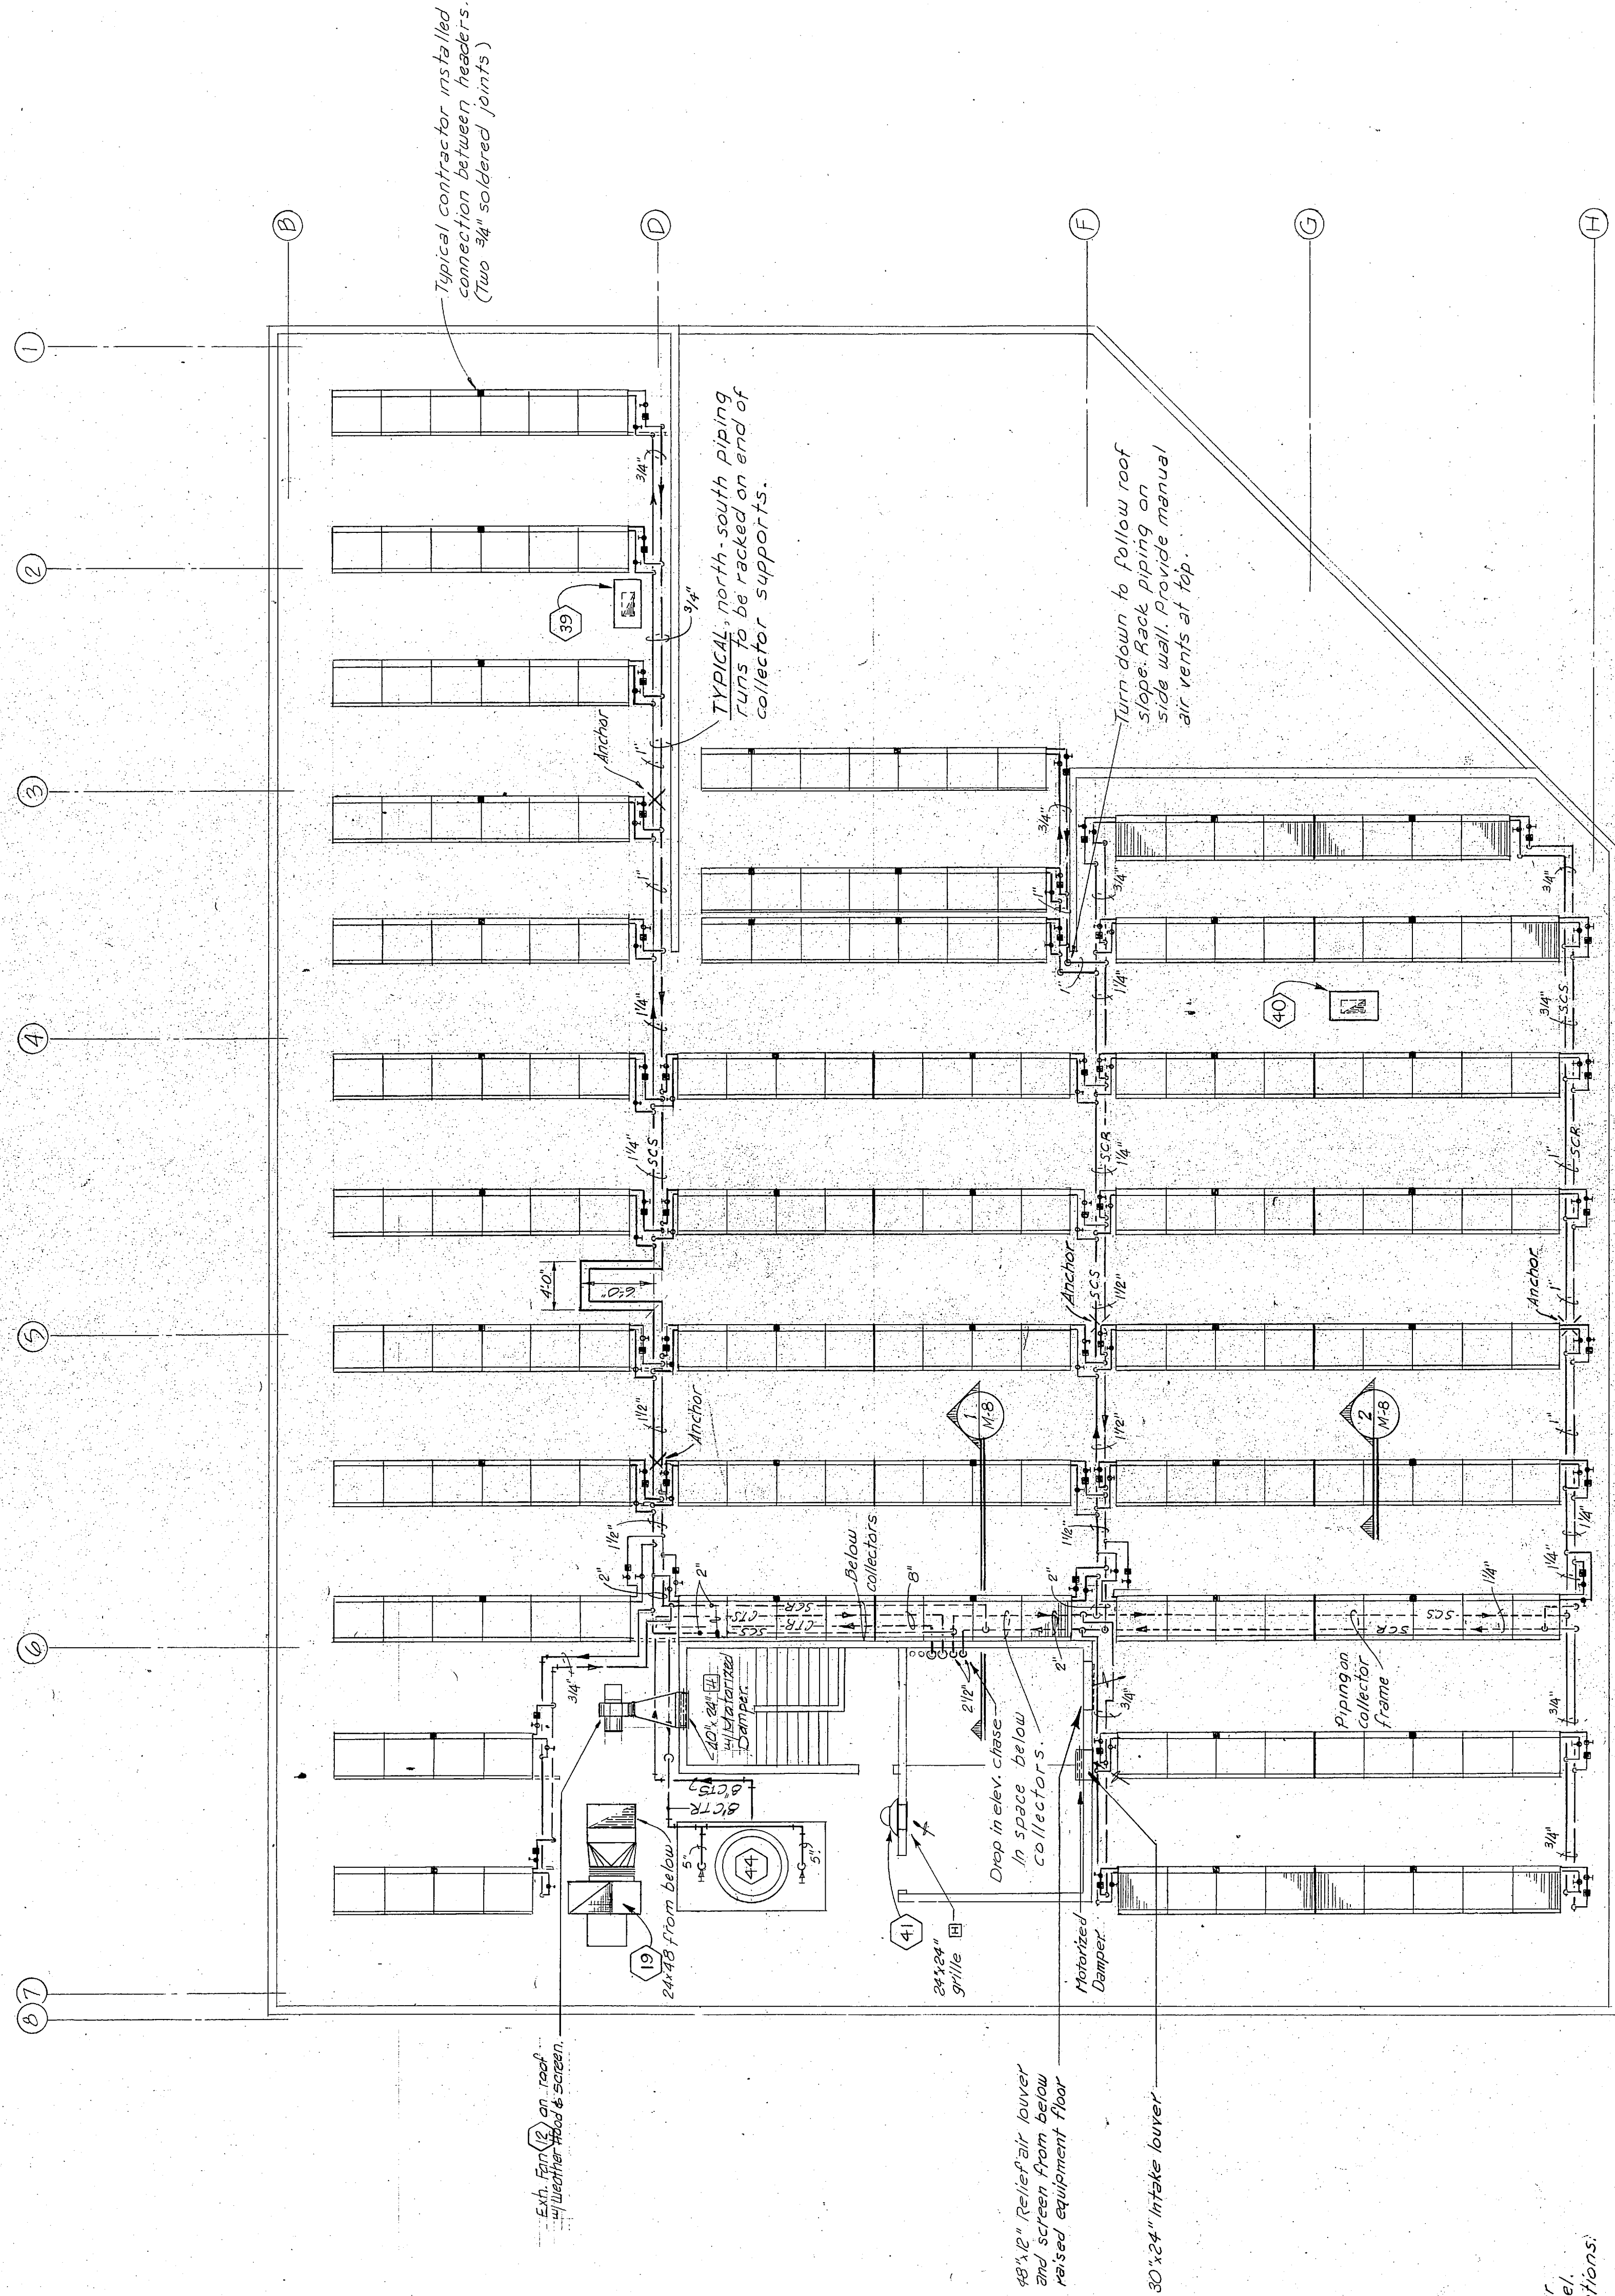


ROOF PLAN SCALE: 1/8"=1'-0"

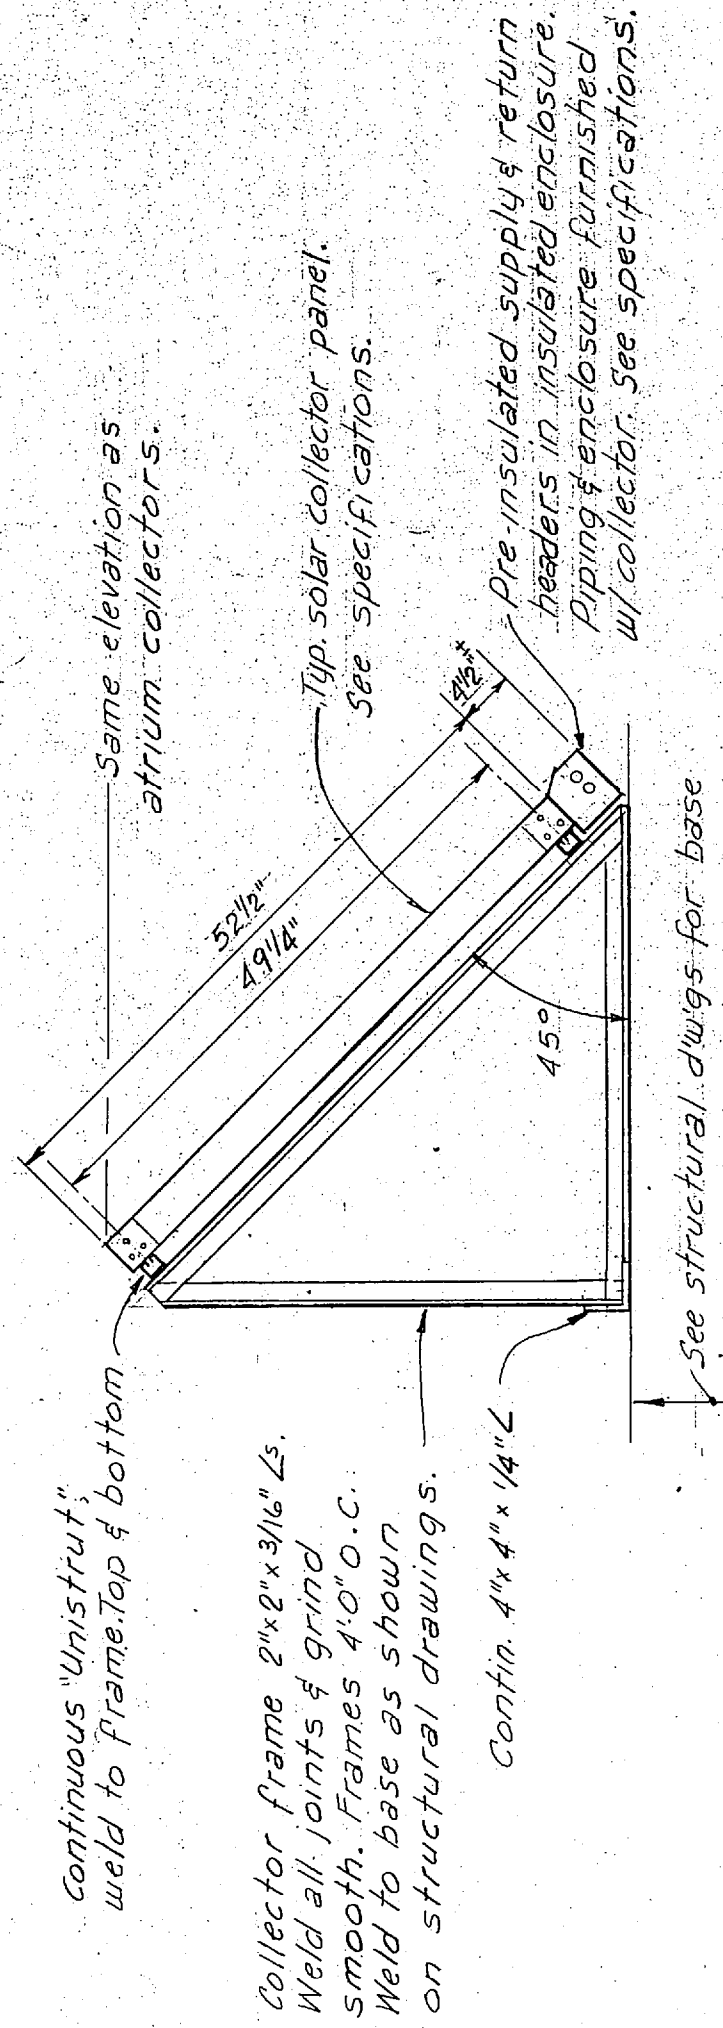

TYPICAL COLLECTOR-SECTION SCALE: 3/4"=1'-0"

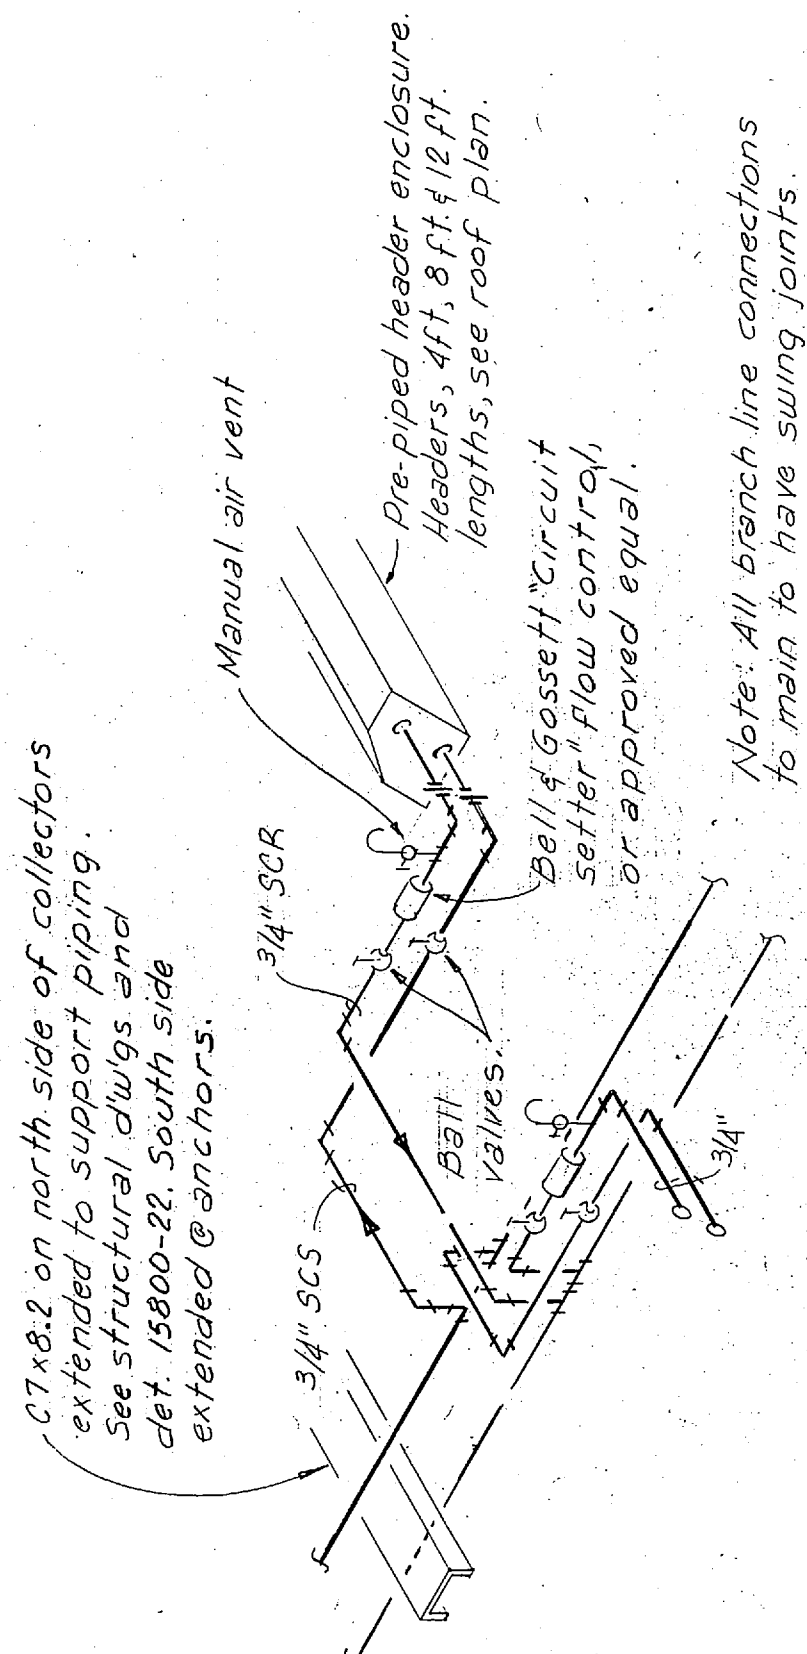

COLLECTOR PIPING DETAIL SCALE: NONE

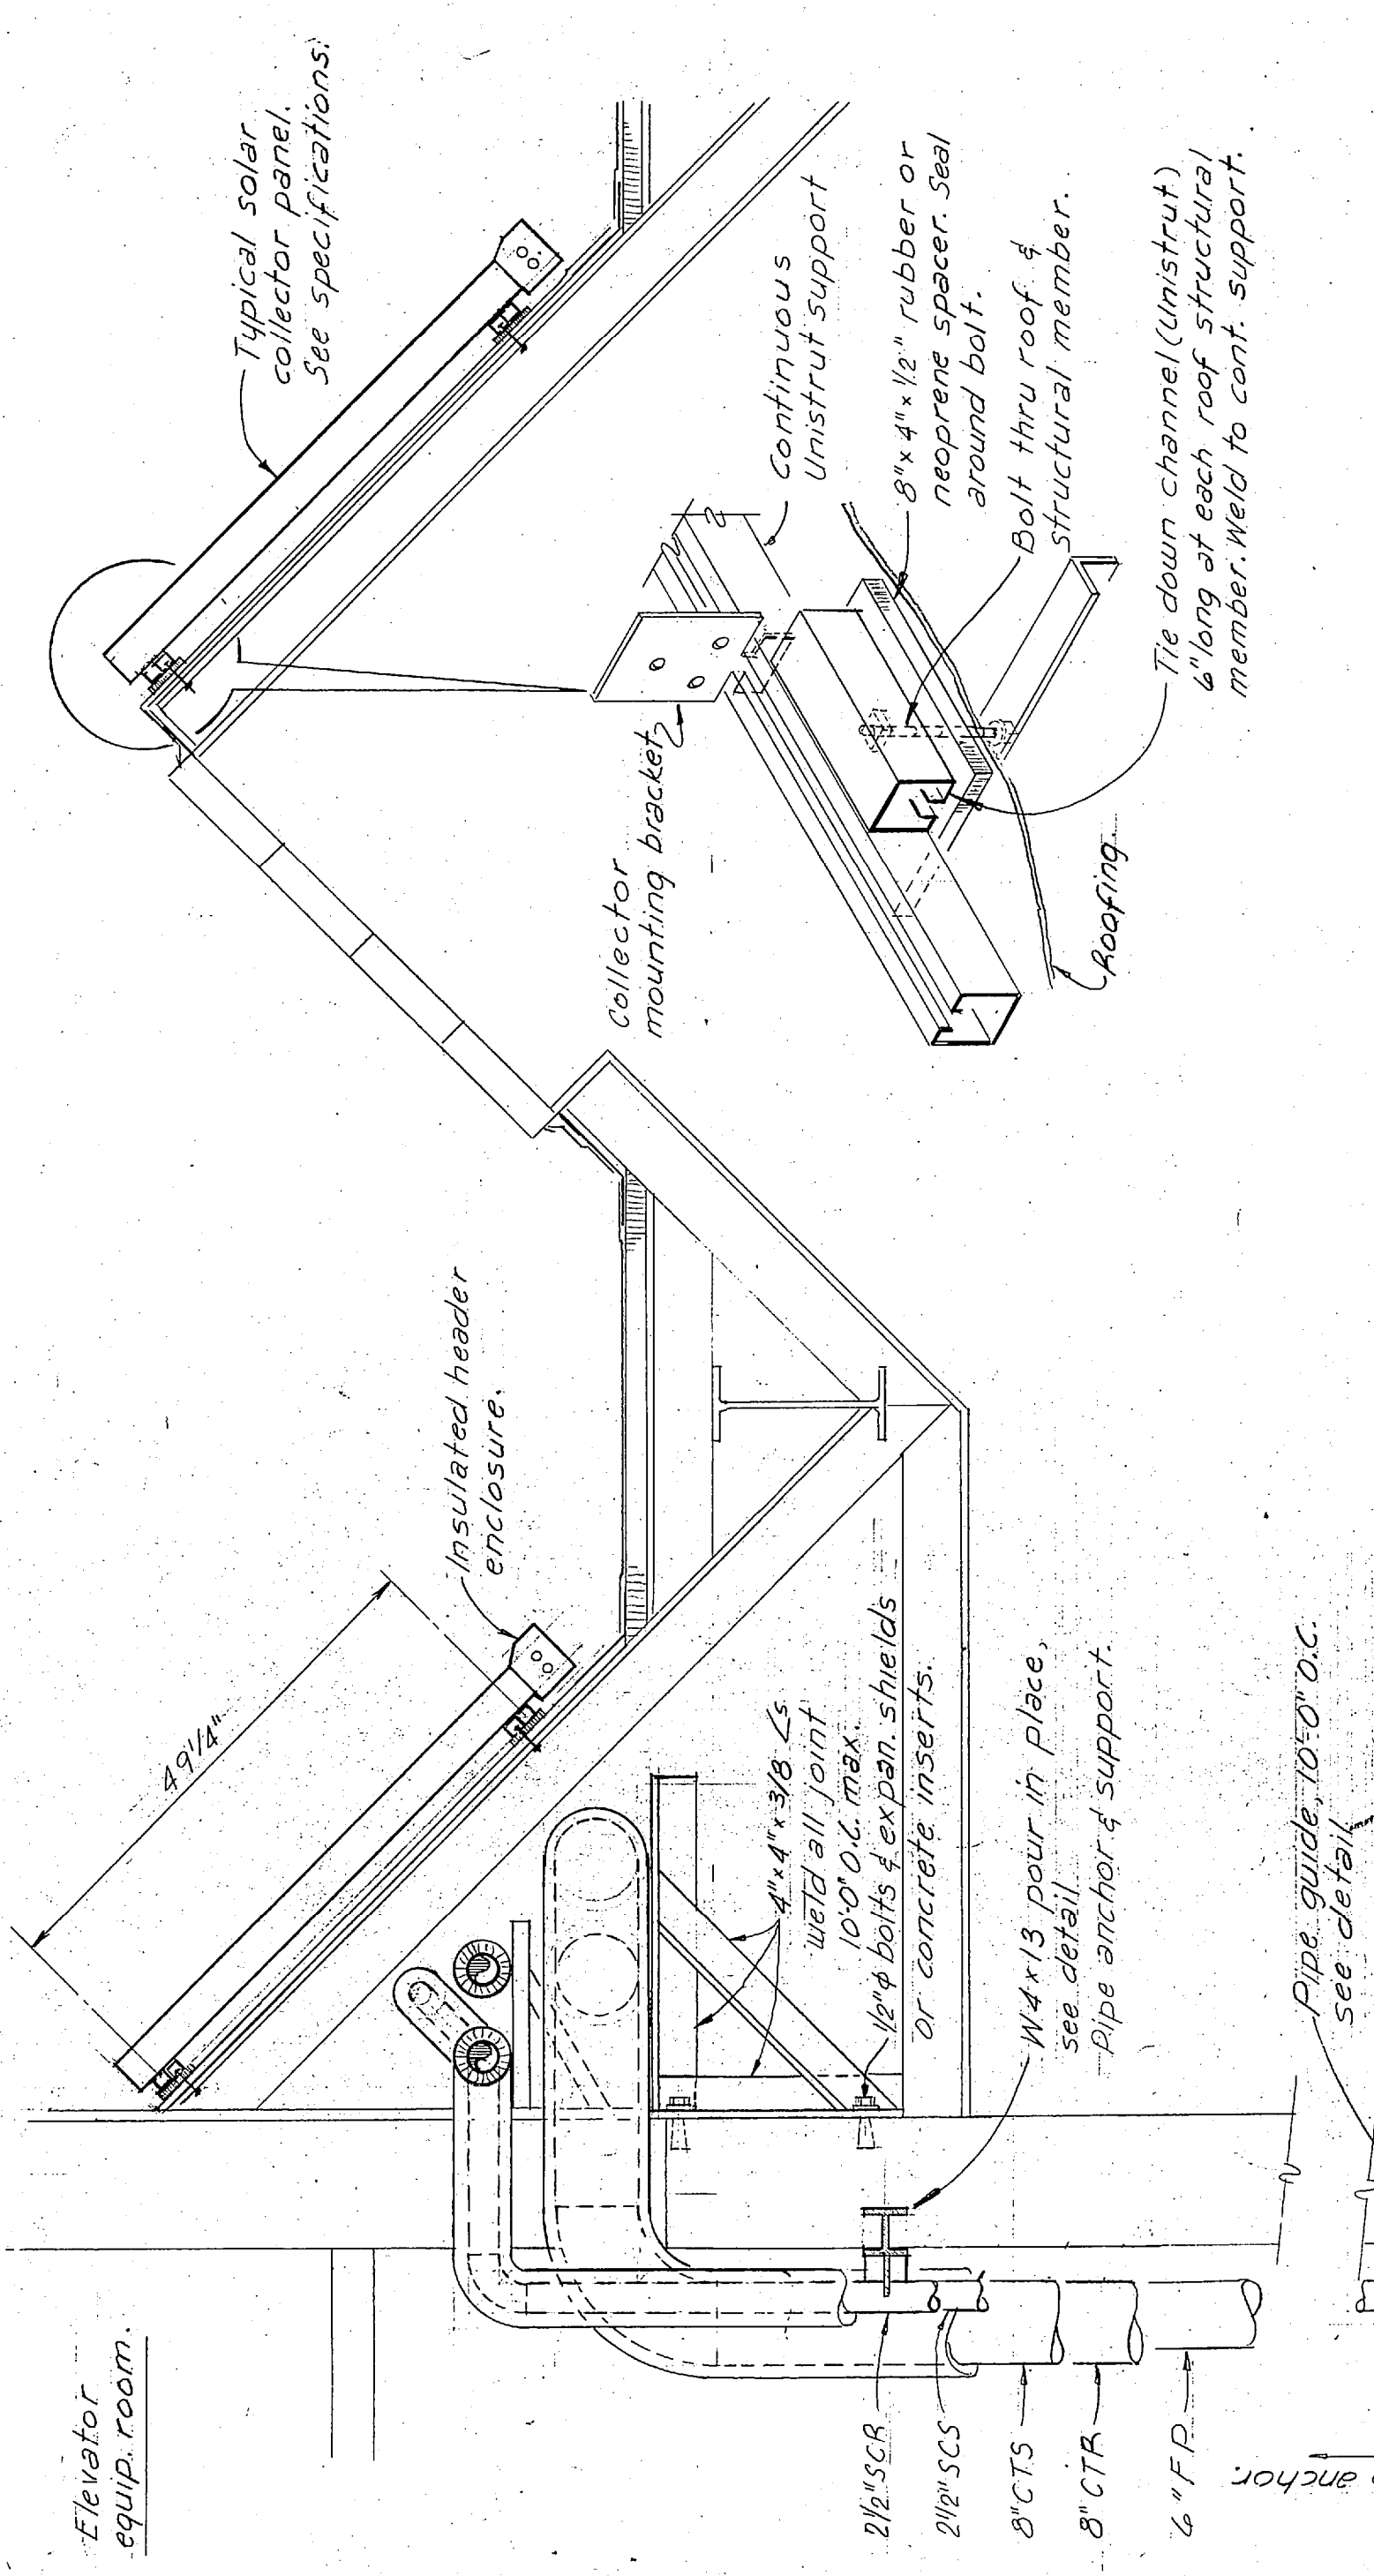

ATRIUM COLLECTOR-SECTION SCALE: 3/4"=1'-0"